


KEYNOTE'S

 
#	DISCRIPTION	QTY
1	TRANSFER SWITCH & MBP	1
2	GENERATOR BOX AND GENERATOR	1
3	EXTERIOR LED LIGHTS	6
4	LP CAGE AND 100# LP TANK	1
5	12V BATTERY	1
6	AMBER FLASHING LIGHT	2
7	CABLE SPLICING DOOR	3
8	FIRE EXTINGUISHER	1
9	AMP PANEL IN O/H, RADIO UNDER O/H	1
10	AIR CONDITION W/ HEAT STRIP	1

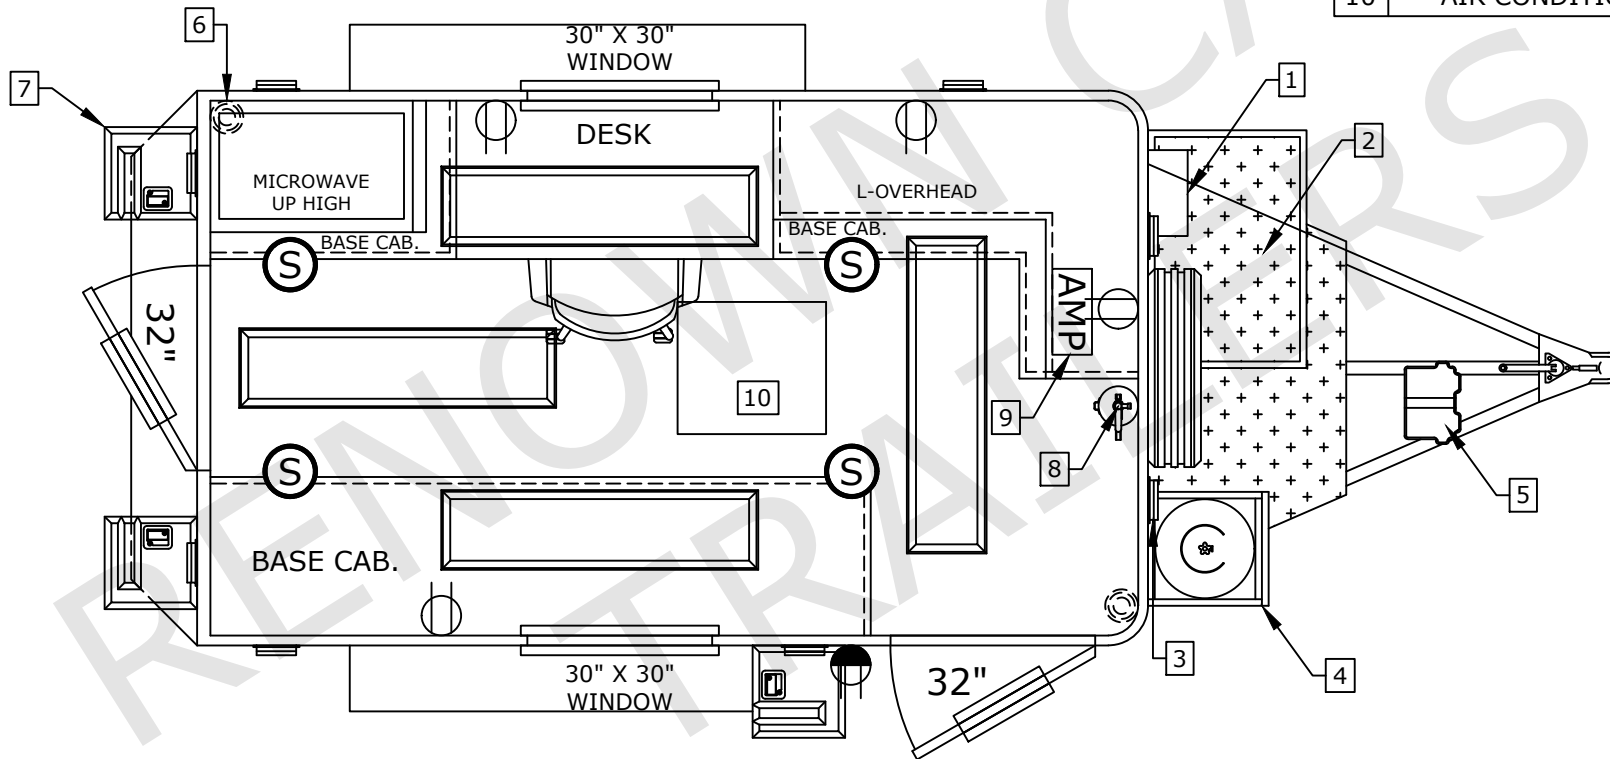

PLEASE REVIEW AND APPROVE THE PRINT SO WE CAN
PROCEED WITH SUBMITTING YOUR ORDER.

FLOOR PLAN

SYMBOL KEY:  = D-RING  = EXTERIOR LED LIGHT

 = 12" X 12" LED LIGHT

SALESPERSON:
PRELIMINARY

REVISION: ORG.	REV. DATE: >
CUSTOMER:	PRELIMINARY



1135 BOWENS MILL RD SW,
DOUGLAS, GA 31533

DRAWN BY: T.J. KEGEBEIN

DWG #: RC-1678

T.J. Kegebein

Date: 11/5/25

TRAILER SIZE:
7X12TA